



WALTER B. MELVIN
ARCHITECTS, LLC

118 WEST 22ND STREET
NEW YORK, NY 10011
WBMA@WBMELVIN.COM

(212) 679-9393 TEL (212) 679-7228 FAX


DATE	ISSUE	DESCRIPTION

PROJECT
COSMOPOLITAN CLUB
122 EAST 66TH STREET, NEW YORK, NY
HVAC FACILITATION

SCALE	PROJECT NO.
N.T.S.	042836
DRAWN BY	DATE
EM,SK	05/23/25
TITLE	

ORIGINAL &
CURRENT VIEWS OF
NORTH ELEVATION

SEAL & SIGNATURE

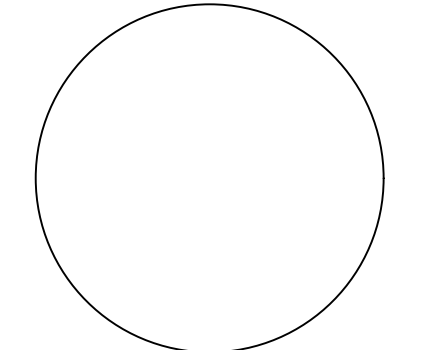

ALL DRAWINGS AND WRITTEN MATERIAL APPEARING HEREIN CONSTITUTE
ORIGINAL AND UNPUBLISHED WORK OF THE ARCHITECT AND MAY NOT BE
REPRODUCED, COPIED OR DISCLOSED WITHOUT WRITTEN CONSENT OF THE ARCHITECT.
DRAWING NO.

LPC1

1 OF 4


1 MUSEUM OF THE CITY OF NEW YORK PHOTO, 3/6/1933

2 LPC DESIGNATION PHOTO

3 WBMA PHOTO, 02/10/2025



THROUGH-WALL AIR CONDITIONER
UNITS TO BE REMOVED.
(3) ABOVE-WINDOW THROUGH-WALL
LOUVERS PROPOSED.

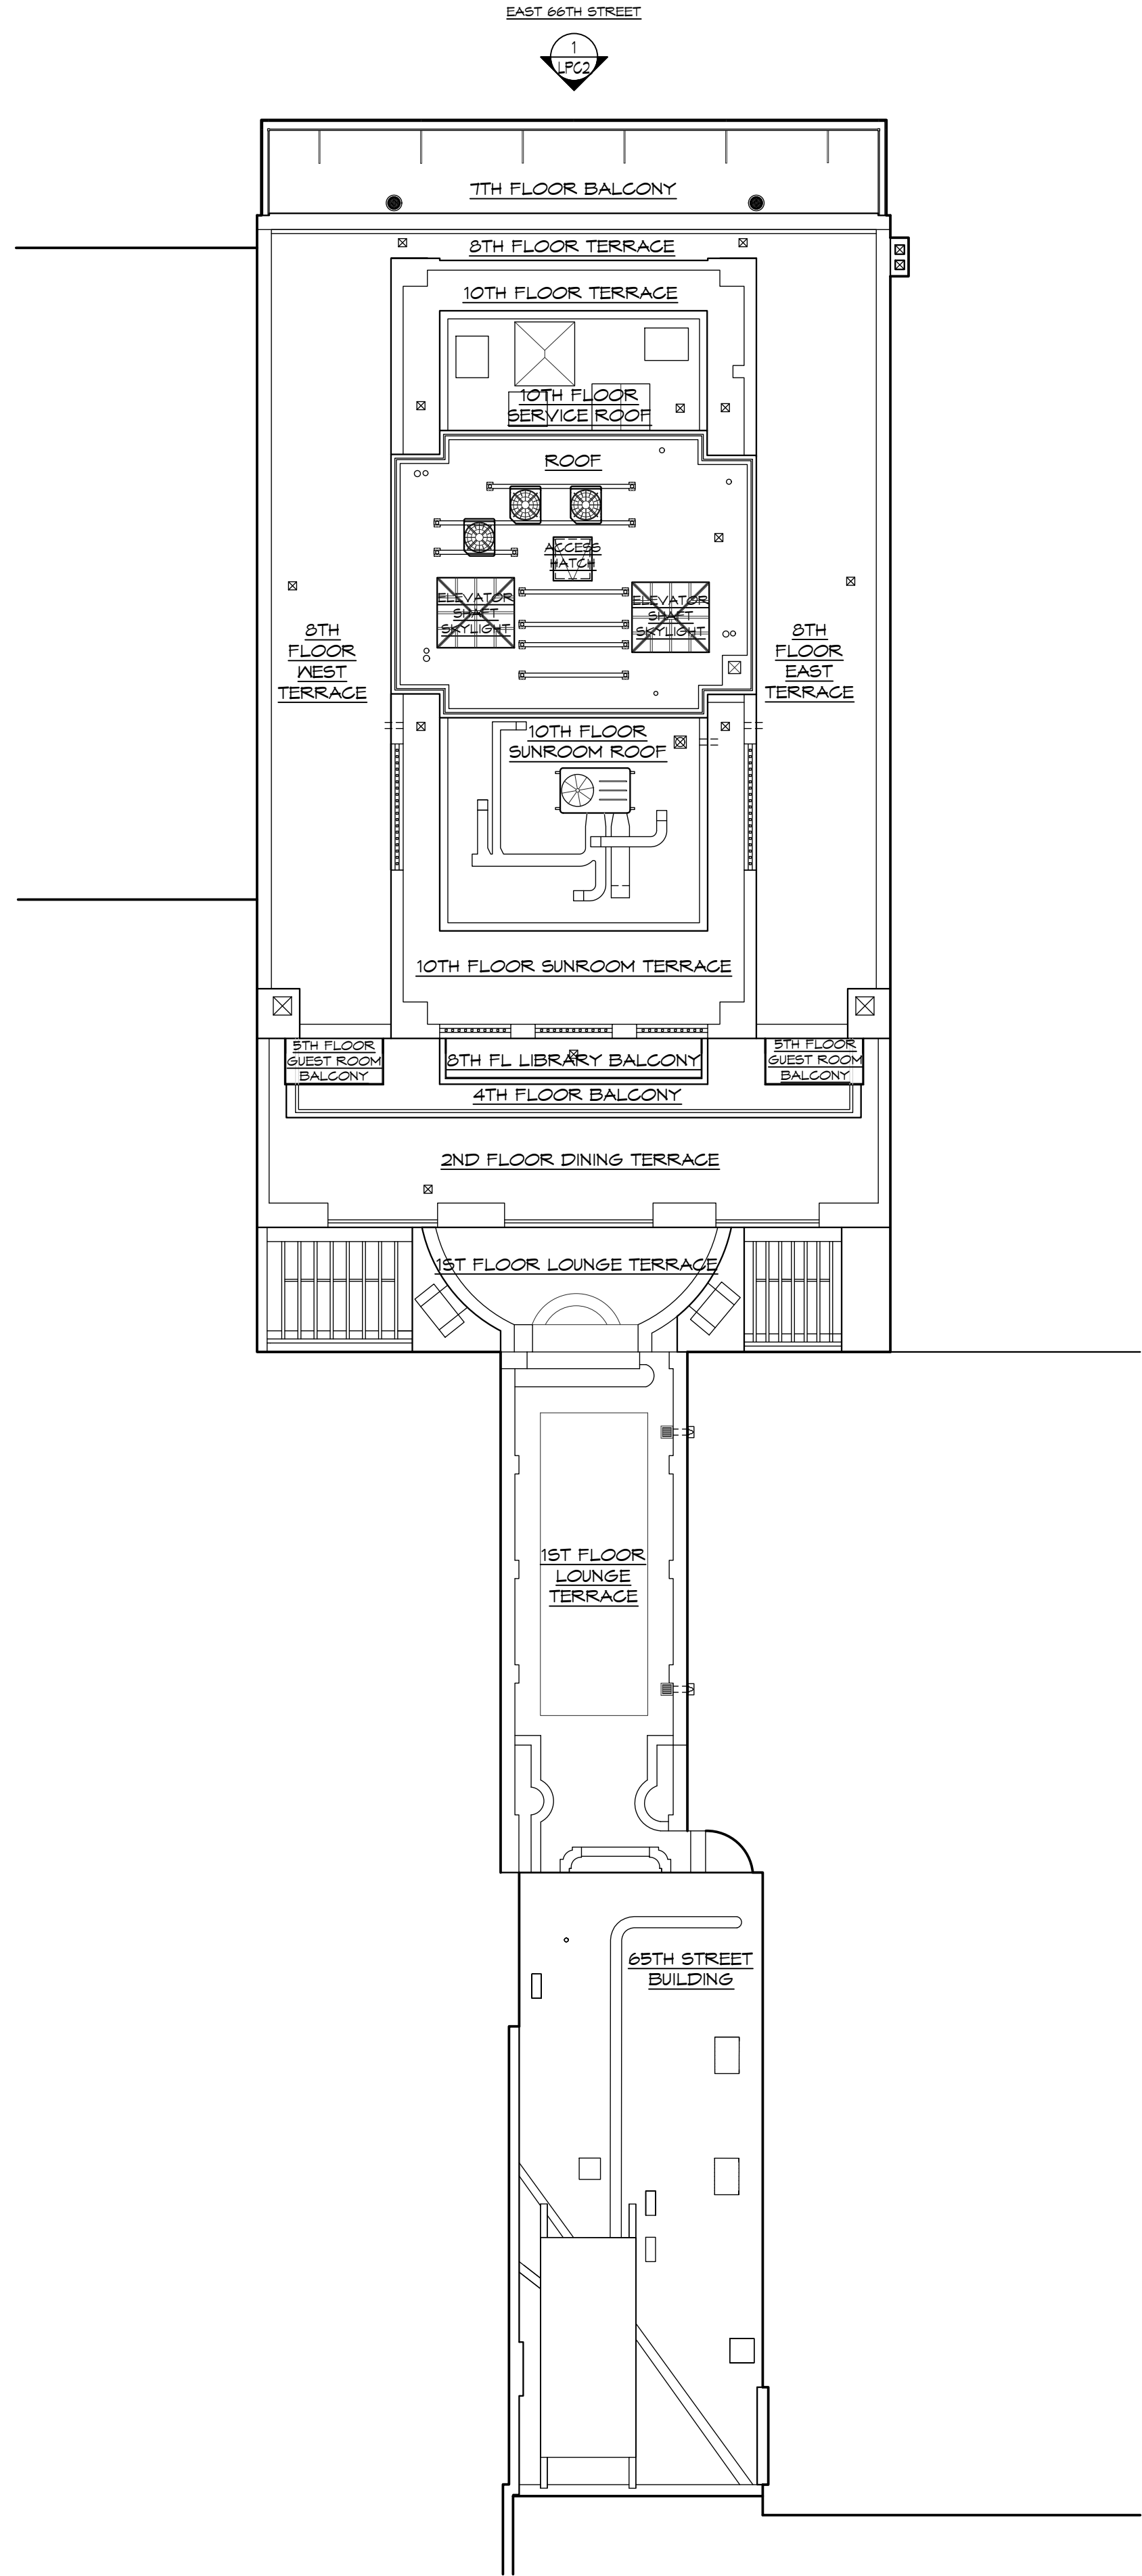

WALTER B. MELVIN
ARCHITECTS, LLC

118 WEST 22ND STREET
NEW YORK, NY 10011
WBMA@WBMELVIN.COM

(212) 679-9393 TEL (212) 679-7228 FAX


DATE	ISSUE	DESCRIPTION

COSMOPOLITAN CLUB
122 EAST 66th STREET, NEW YORK, NY
HVAC FACILITATION

SCALE	PROJECT NO.
AS NOTED	042836
DRAWN BY	DATE
EM	05/23/25
TITLE	

EXISTING
CONDITIONS


SEAL & SIGNATURE

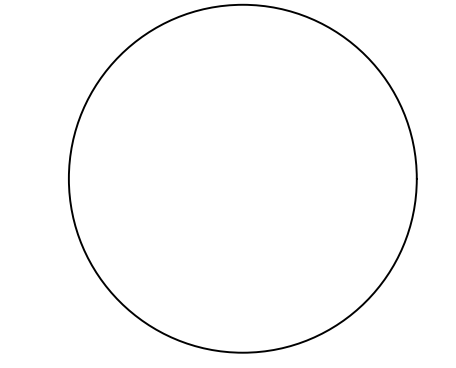

ALL DRAWINGS AND WRITTEN MATERIAL APPEARING HEREIN CONSTITUTE
ORIGINAL AND UNPUBLISHED WORK OF THE ARCHITECT AND MAY NOT BE
DUPLICATED, REPRODUCED OR DISCLOSED WITHOUT WRITTEN CONSENT OF THE ARCHITECT.
DRAWING NO.

LPC2

2 OF 4

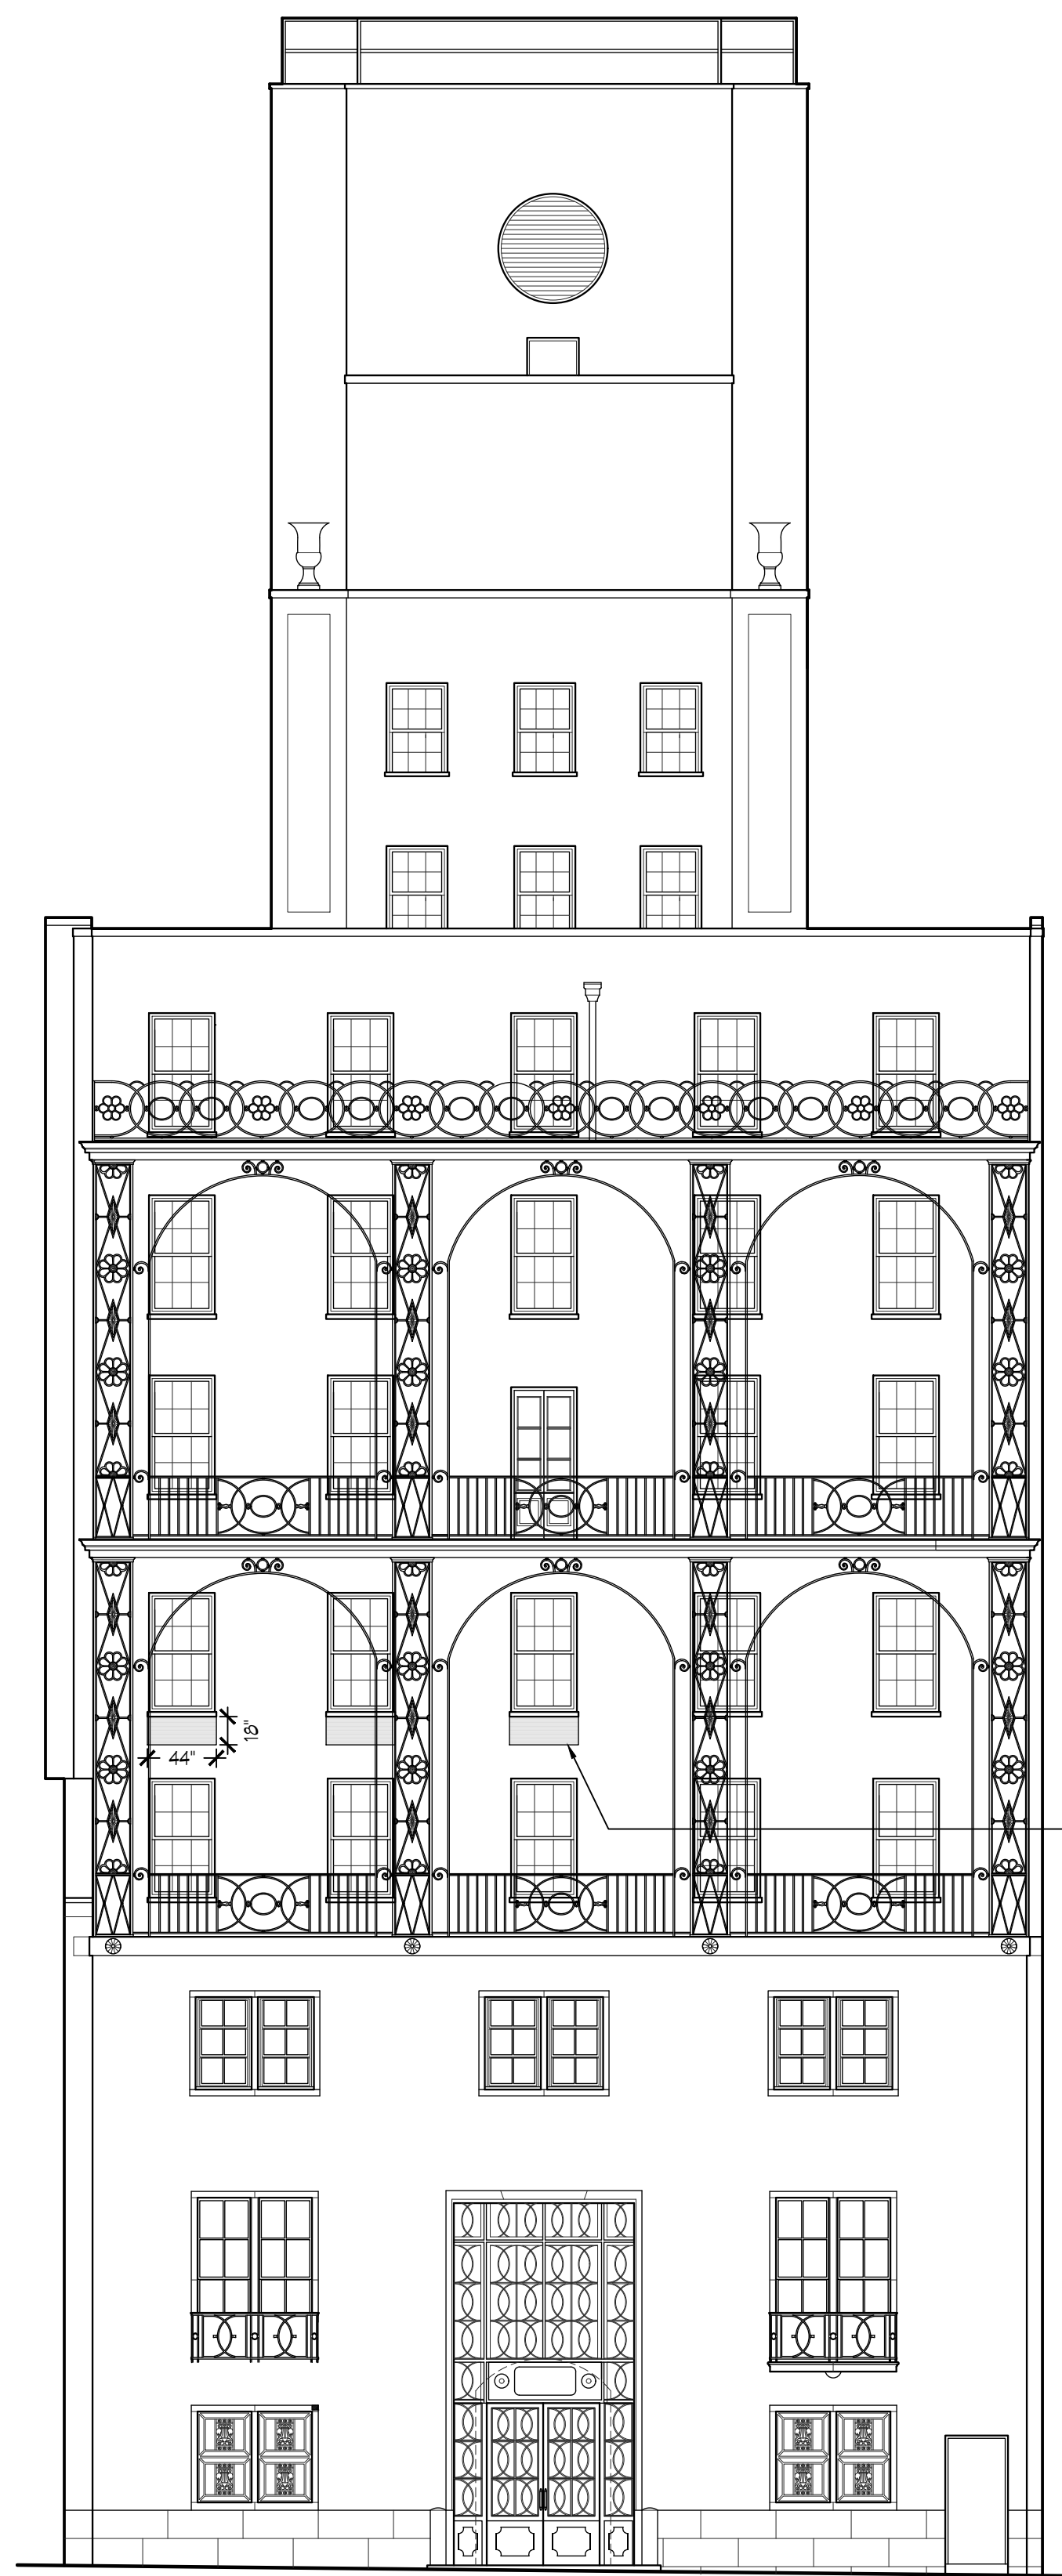

1 EXISTING NORTH ELEVATION
SCALE: 1/8" = 1'-0"


ELEVATOR BLKHD
10TH FL.
9TH FL.
8TH FL.
7TH FL.
6TH FL.
5TH FL.
4TH FL.
3RD FL.
2ND FL.
1ST FL.
GROUND FL.



2 NORTH FACADE FROM THE ARMORY (ca. 2020)



3 EXISTING 4th FLOOR THROUGH-WALL PENETRATIONS

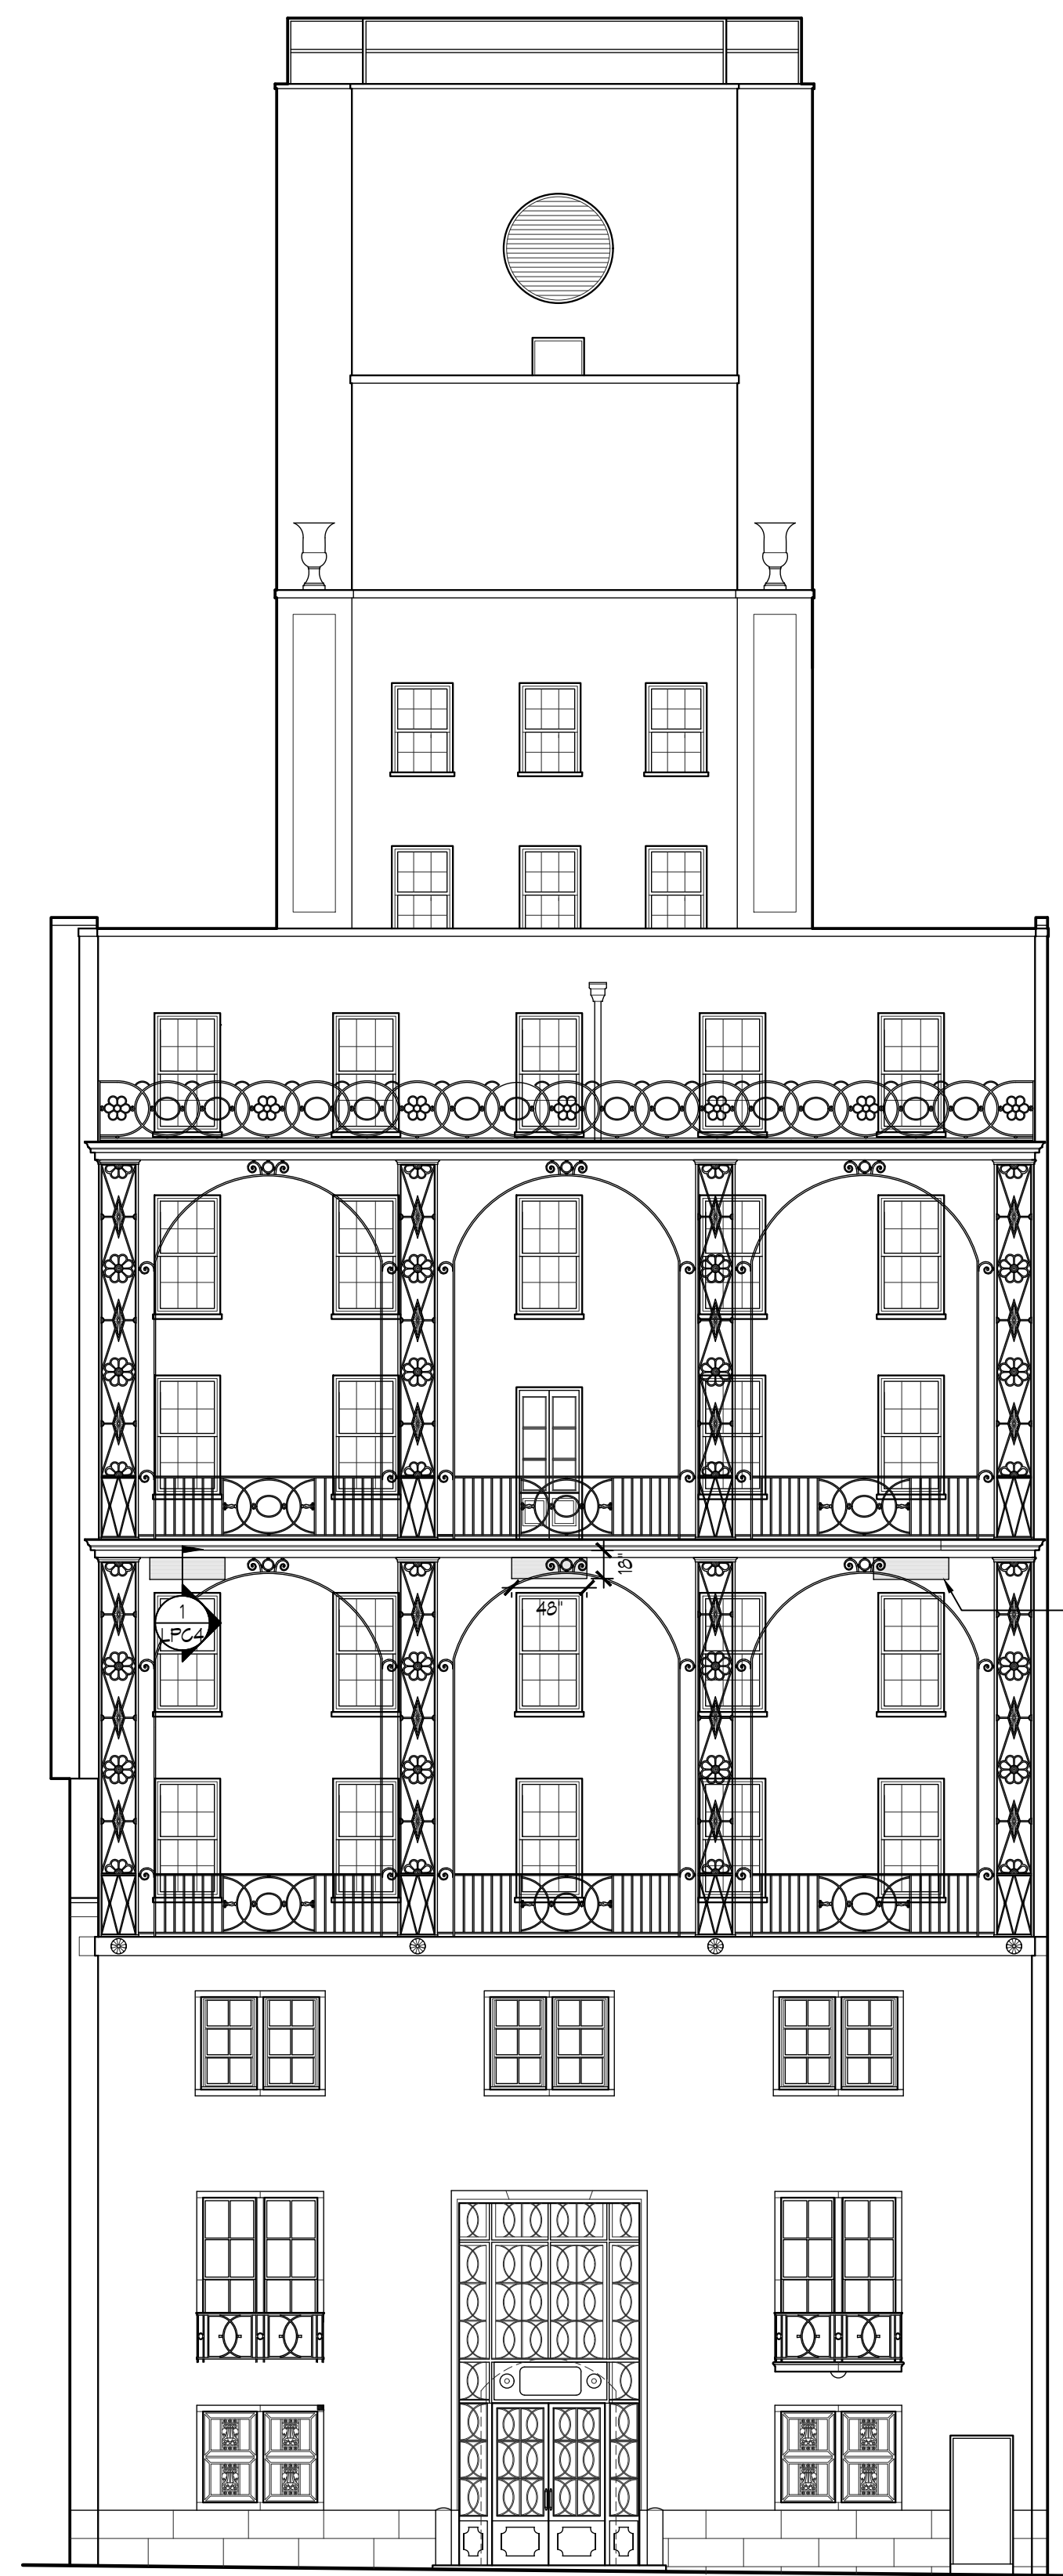

4 PROPOSED NORTH ELEVATION
SCALE: 1/8" = 1'-0"

ELEVATOR BLKHD
10TH FL.
9TH FL.
8TH FL.
7TH FL.
6TH FL.
5TH FL.
4TH FL.
3RD FL.
2ND FL.
1ST FL.
GROUND FL.

WALTER B. MELVIN
ARCHITECTS, LLC

118 WEST 22ND STREET
NEW YORK, NY 10011
WBMA@WBMELVIN.COM

(212) 679-9393 TEL (646) 786-4396 FAX


DATE SCALE DESCRIPTION

PROJECT
COSMOPOLITAN CLUB
122 EAST 66th STREET, NEW YORK, NY
HVAC FACILITATION

SCALE PROJECT NO.
AS NOTED 042836
DRAWN BY DATE
EM,SW 05/23/2025
TITLE

NORTH
ELEVATION


SEAL & SIGNATURE

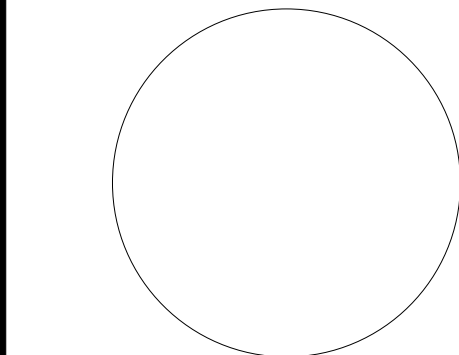

ALL DRAWINGS AND WRITTEN MATERIAL APPEARING HEREIN CONSTITUTE
ORIGINAL AND UNPUBLISHED WORK OF THE ARCHITECT AND MAY NOT BE
DUPLICATED, USED OR DISCLOSED WITHOUT WRITTEN CONSENT OF THE ARCHITECT.
DRAWING NO.

LPC3

3 OF 4

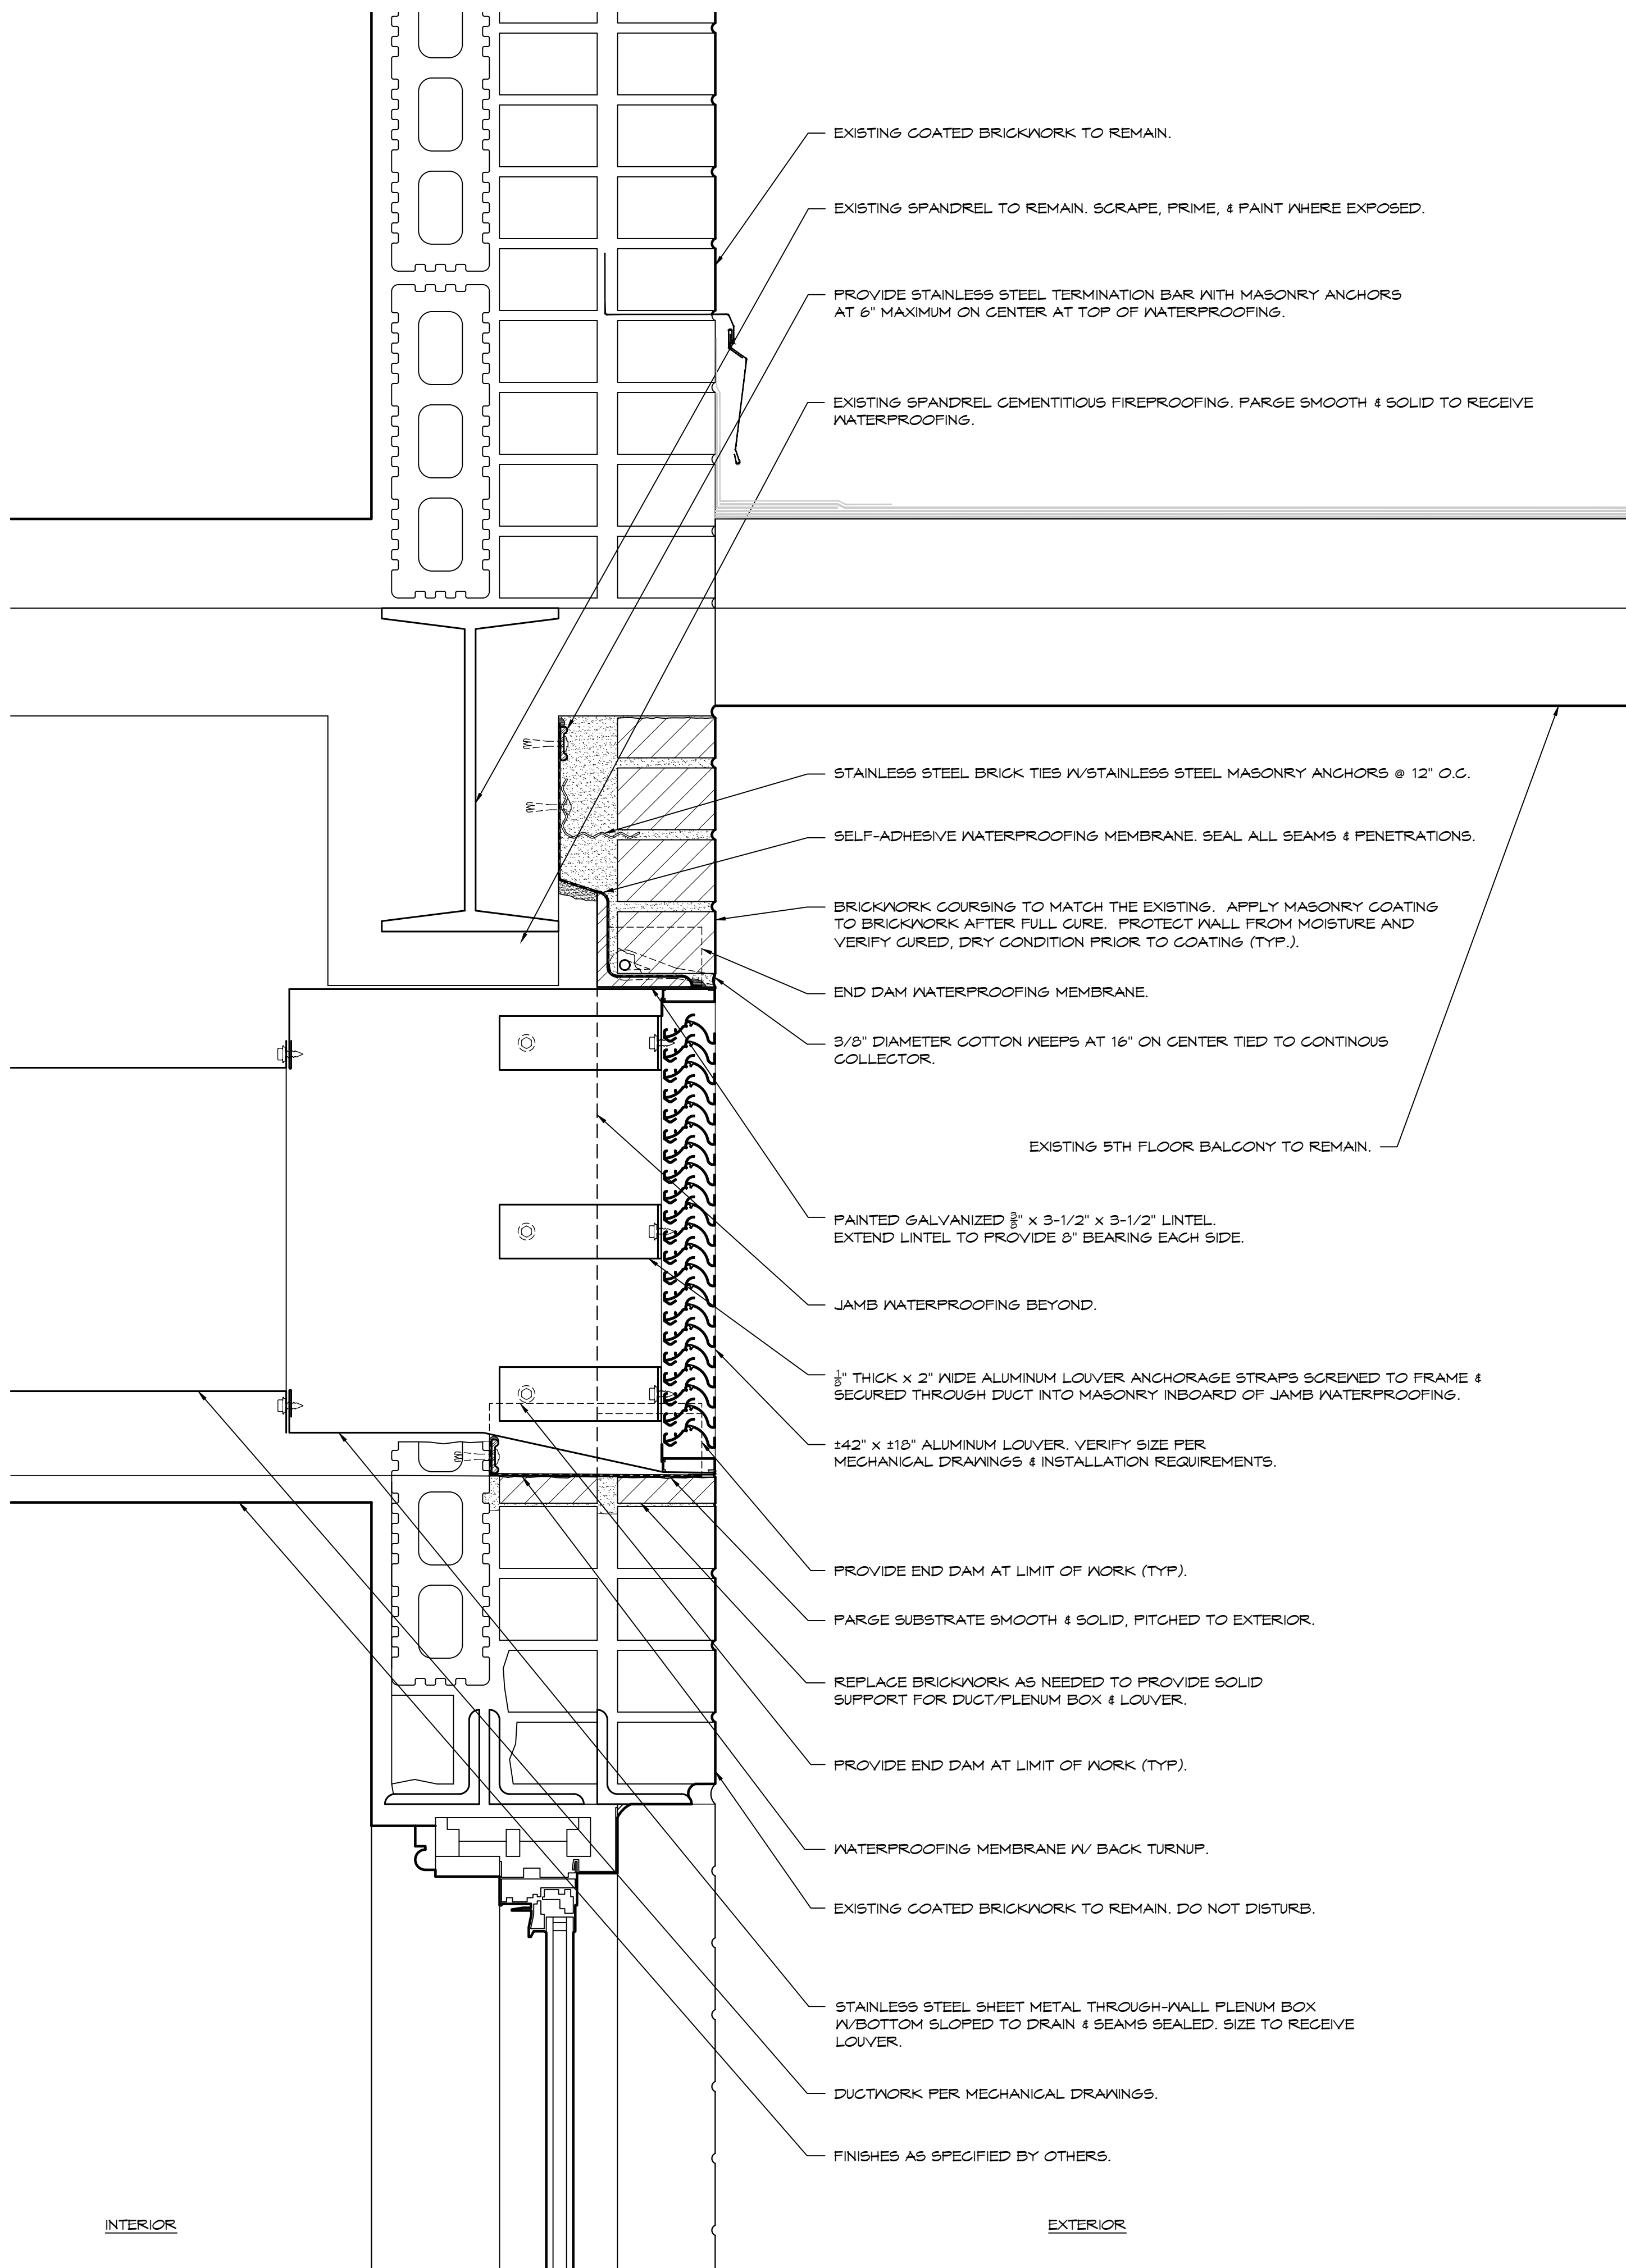

1 NORTH WALL DUCT PENETRATION SECTION
SCALE: 3"=1'-0"

0 3 6 9
SCALE IN INCHES

WALTER B. MELVIN
ARCHITECTS, LLC

118 WEST 22ND STREET
NEW YORK, NY 10011
WBMA@WBMELVIN.COM

(212) 679-9193 TEL (646) 786-4396 FAX


DATE	SCALE	DESCRIPTION

PROJECT
COSMOPOLITAN CLUB
122 EAST 66th STREET, NEW YORK, NY
HVAC FACILITATION

SCALE	PROJECT NO.
3"=1'-0"	042836
DRAWN BY	DATE
EM, KR	05/23/2025
TITLE	

DUCT
PENETRATION
DETAILS

SEAL & SIGNATURE

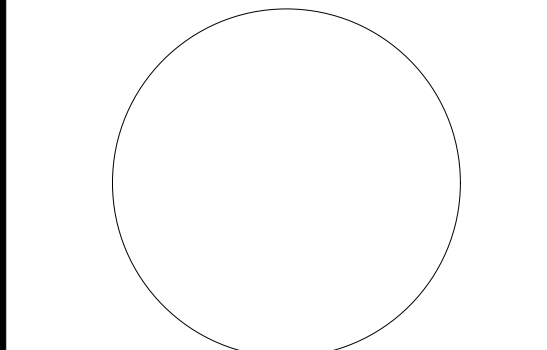

ALL DRAWINGS AND WRITTEN MATERIAL APPEARING HEREIN CONSTITUTE
ORIGINAL AND UNPUBLISHED WORK OF THE ARCHITECT AND MAY NOT BE
REPRODUCED, COPIED OR DISCLOSED WITHOUT WRITTEN CONSENT OF THE ARCHITECT.
DRAWING NO.

LPC4

4 OF 4